


ARCHITECTURAL EXHIBITS


PRECAST STONE MINARET

CUSTOM POWDER COATED METAL DOME. DECORATIVE INTERIOR STRUCTURE PER ARCHITECTURAL PLANS

- CUSTOM DECORATIVE HARDWOOD DOOR STAINED TO BE DARK — PER OWNER.
- INTERIOR GLASS DOOR TO BE INSTALLED PER PLANS

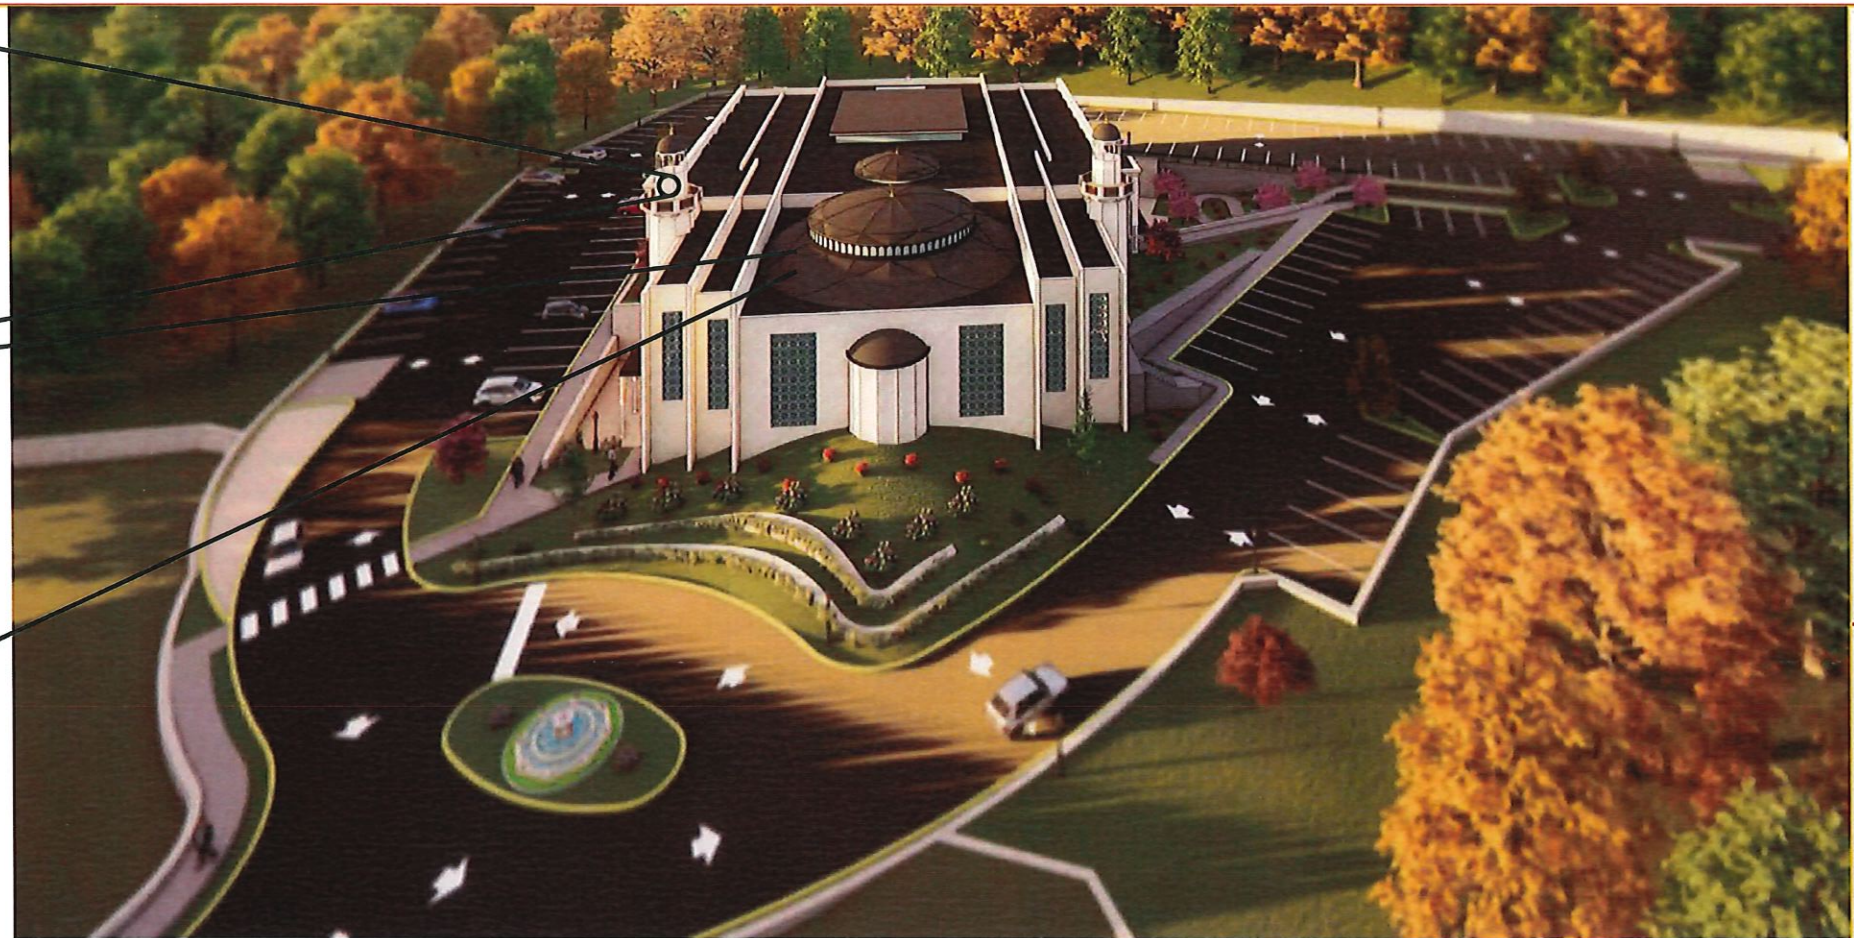

IPRAY HOUSE
225 COLFAX ROAD
BLOCK 3517, LOT 26
TOWNSHIP OF WAYNE
PASSAIC COUNTY NEW JERSEY

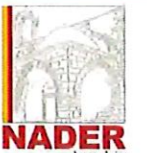

THE NADER GROUP, LLC
Architects, Engineers & Surveyors
111 Mill Street
Hockessin, NJ 07040

p. 908.850.3500 | f. 908.441.5803
e. wassim.nader@thenadergroup.com

www.naderhouseofdesign.com

CERTIFICATE OF AUTHORIZATION
Engineering & Survey
No. 24GA28213500
Architecture
No. 21AC00126800


Karen J. Wenschhop
KAREN J. WENSCHHOP
ARCHITECT, LICENSE
NO. 21A102235800

CAUTION: THIS DOCUMENT
MAY CONTAIN A RAISED
EXPRESSION SEAL OF THE
PROFESSIONAL TO BE AN
AUTHORIZED ORIGINAL.

**PLANNING
BOARD SET**

CERAMIC CLADDING VENEER TILE TO EMULATE LIMESTONE, WITH LOW PROFILE CONCEALED JOINTS OR APPROVED EQUAL. FINAL SYSTEM TO BE COORDINATED W/ ARCHITECT.

- CUSTOM POWDER COATED METAL SCREENS. FINAL PATTERN TO BE COORDINATED W/ ARCHITECT

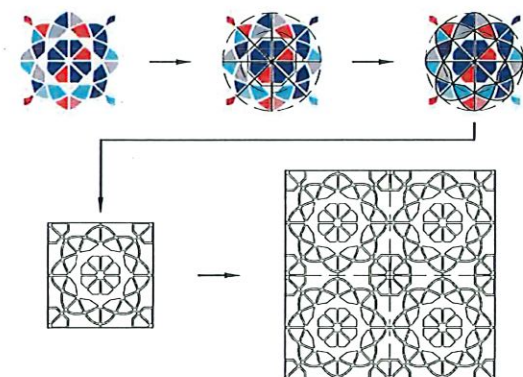

ALL RAILINGS TO BE POWDER COATED BLACK ALUMINUM RAILING.

NO.	DATE	REVISION	CHK
DRAWN BY: MC			
SCALE: AS SHOWN			
DATE: JUNE 6TH, 2025			
JOB NO. 24TNG022			



MATERIALS BOARD

ENGINEERING NO. **A-102**

© 2025 NADER GROUP, NADER HOUSE OF DESIGN

© 2026 THE NADER GROUP LLC

A-2 6/1/26

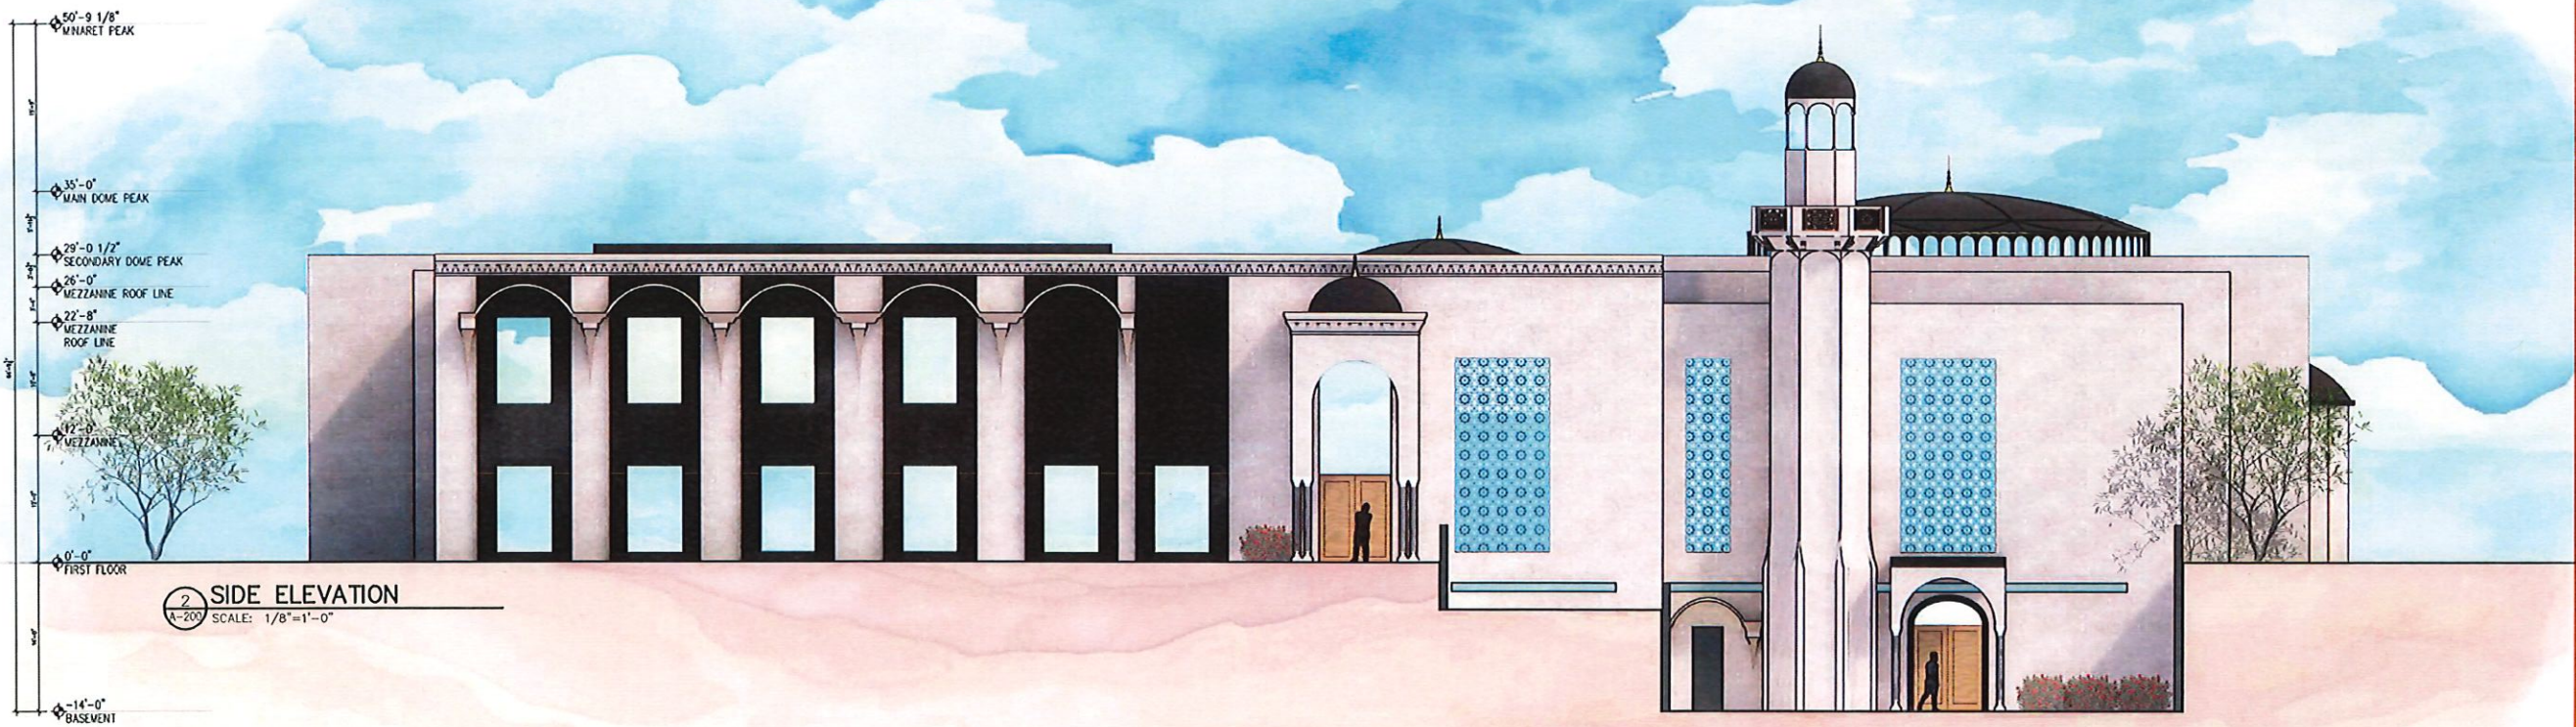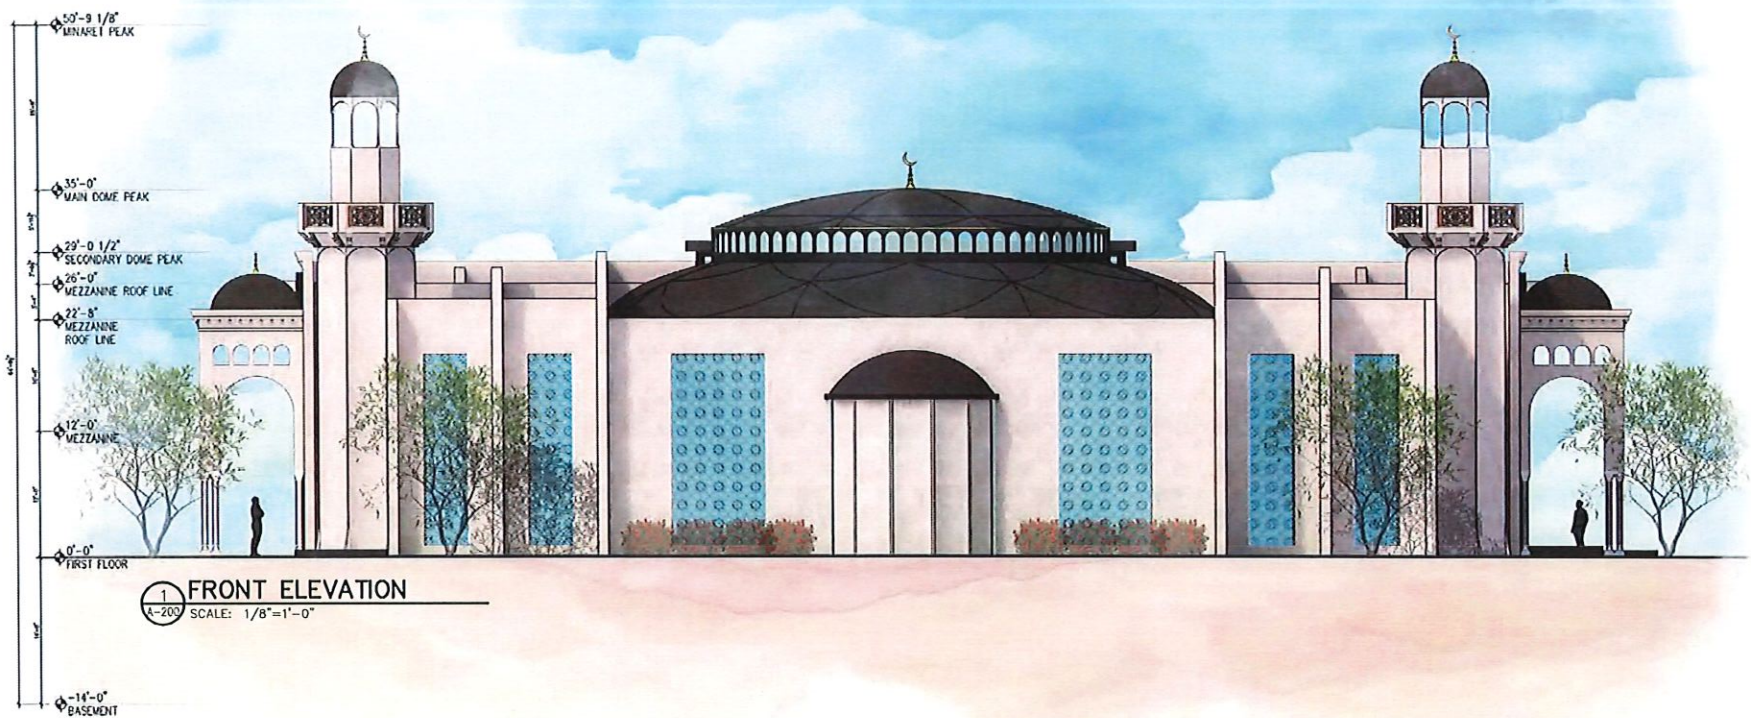

IPRAY HOUSE
225 COLFAX ROAD
BLOCK 3517, LOT 26
TOWNSHIP OF WAYNE
PASSAIC COUNTY NEW JERSEY



THE NADER GROUP, LLC
Architects, Engineers & Surveyors
111 Mill Street
Hockessin, NJ 07840
p. 908.850.3500 | f. 908.441.5803
e. wassim.nader@thenadergroup.com
www.naderhouseofdesign.com

CERTIFICATE OF AUTHORIZATION
Engineering & Survey
No. 24GA28213500
Architect
No. 21AC00126800

Karen J. Wenschhof
KAREN J. WENSCHHOF
ARCHITECT, LICENSE
NO. 21A102235800
CAUTION: THIS DOCUMENT
MUST CONTAIN A RAISED
EXPRESSION SEAL OF THE
PROFESSIONAL TO BE AN
AUTHORIZED ORIGINAL

PLANNING
BOARD SET



NO.	DATE	REVISION	CHK
DRAWN BY: MC			
SCALE: AS SHOWN			
DATE: JUNE 6TH, 2025			
JOB NO. 24TN0022			

ELEVATIONS


DRAWING NO. **A-103**

© 2025 NADER GROUP, NADER HOUSE OF DESIGN

A-3 6/1/24

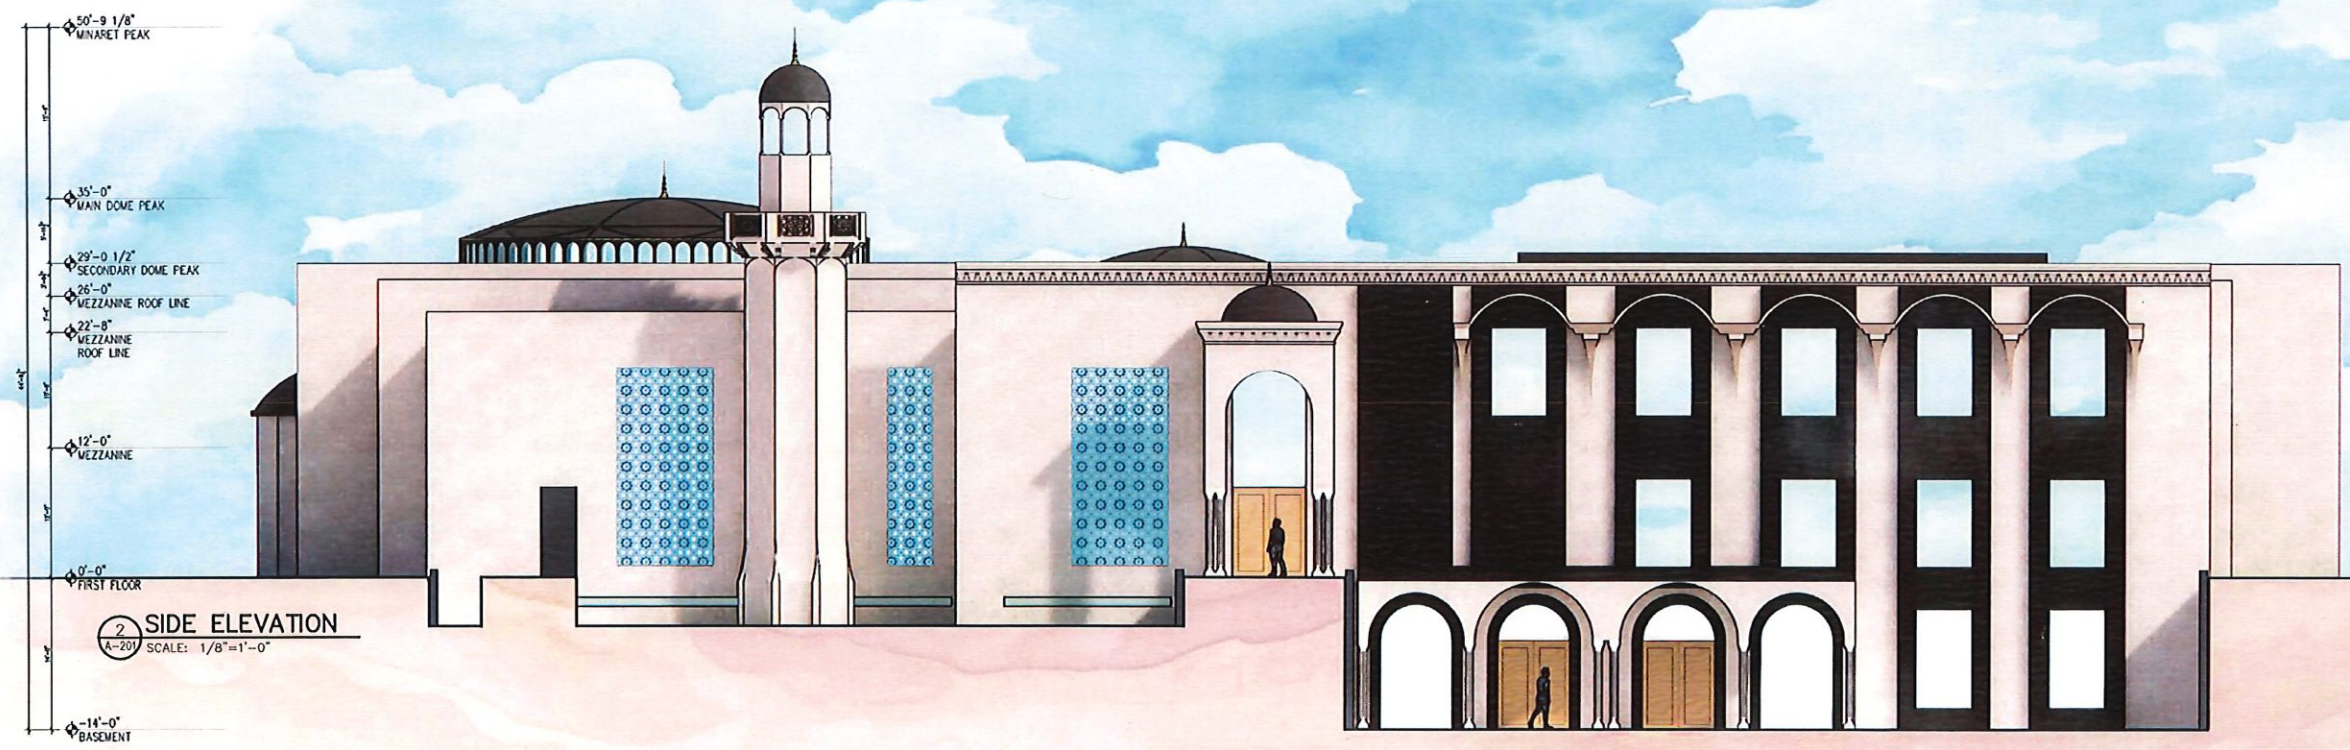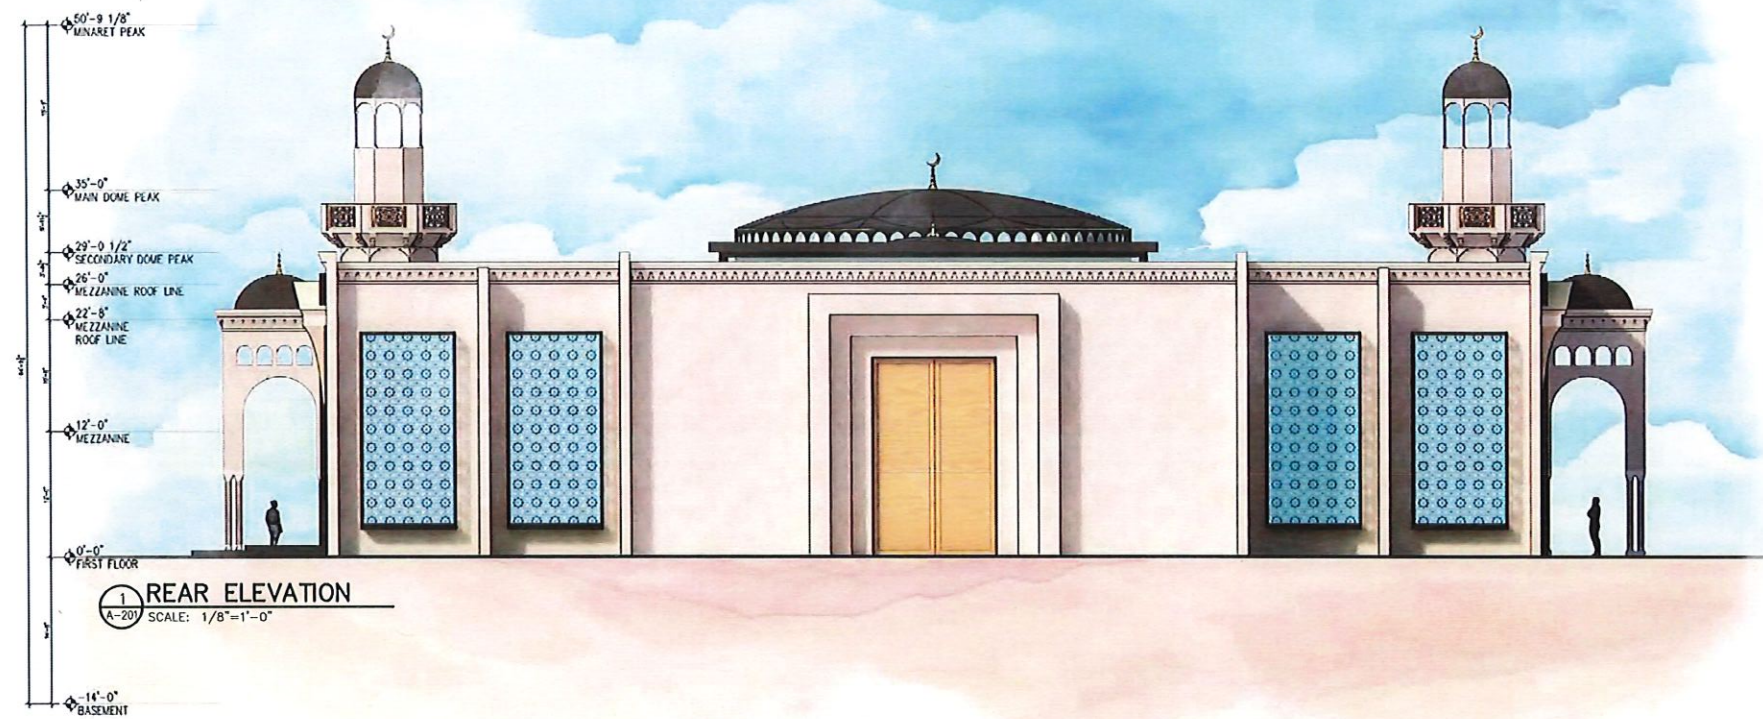

IPRAY HOUSE
225 COLFAX ROAD
BLOCK 3517, LOT 26
TOWNSHIP OF WAYNE
PASSAIC COUNTY NEW JERSEY

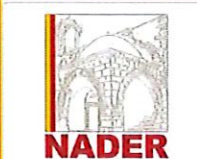

THE NADER GROUP, LLC
Architects, Engineers & Surveyors
111 Mill Street
Hackettstown, NJ 07840

p. 908.850.3500 | f. 908.441.5803
e. waasim.nader@thenadergroup.com

www.naderhouseofdesign.com

CERTIFICATE OF AUTHORIZATION
Engineering & Survey
No. 24GA28213500
Architecture
No. 21AC00126900

Karen J. Wenschhop
KAREN J. WENSCHHOP
ARCHITECT, LICENSE
NO. 21A102239800

CAUTION: THIS DOCUMENT
MUST CONTAIN A RAISED
EXPRESSION SEAL OF THE
PROFESSIONAL TO BE AN
AUTHORIZED ORIGINAL

PLANNING
BOARD SET

NO.	DATE	REVISION	CHK


DRAWN BY: MC
SCALE: AS SHOWN
DATE: JUNE 6TH, 2025
JOB NO. 24TNG022

ELEVATIONS

A-104


© 2025 NADER GROUP, NADER HOUSE OF DESIGN

A-4 6/1/26

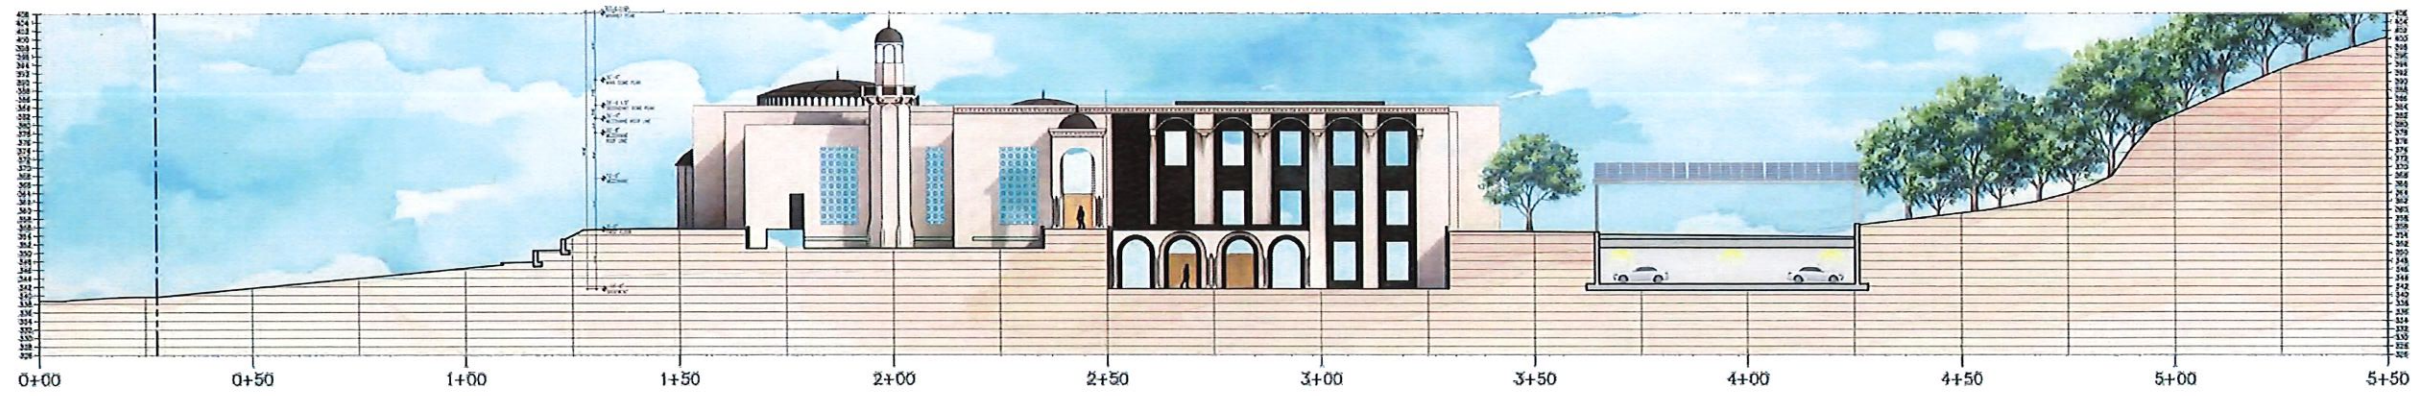

PROPOSED RENDERED SITE SECTION
SCALE: 1"=20'-0"

IPRAY HOUSE
225 COLFAX ROAD
BLOCK 3517, LOT 26
TOWNSHIP OF WAYNE
PASSAIC COUNTY NEW JERSEY

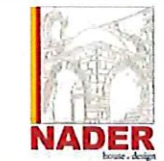


THE NADER GROUP, LLC
Architect, Engineer & Surveyors
111 Mill Street
Hackensack, NJ 07640


p. 908.850.3500 | f. 908.441.5803
e. wassim.nader@thenadergroup.com

www.naderhouseofdesign.com

 CERTIFICATE OF AUTHORIZATION
Engineering & Survey
No. 24GA28213500
Architecture
No. 21AC00126800


KAREN J. WENSCHHOF
ARCHITECT, LICENSE
NO. 21A102235800
CAUTION: THIS DOCUMENT
MUST CONTAIN A RAISED
IMPRESSION SEAL OF THE
PROFESSIONAL TO BE AN
AUTHORIZED ORIGINAL.

PLANNING
BOARD SET

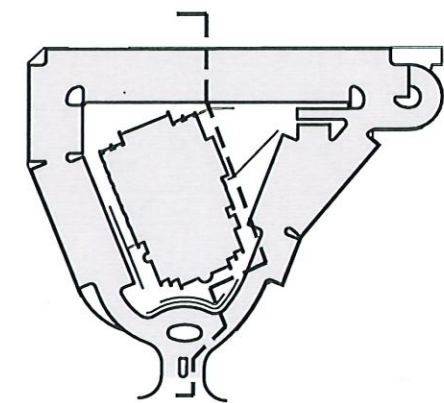

KEY MAP
SCALE: NTS


NO.	DATE	REVISION	CHK

DRAWN BY: MC
SCALE: AS SHOWN
DATE: JUNE 6TH, 2025
JOB NO. 24TNG022


RENDERED SITE
SECTION

DATE: 6/1/24
A-105

© 2025 NADER GROUP, NADER HOUSE OF DESIGN

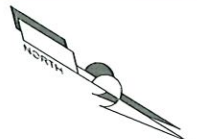

IPRAY HOUSE
225 COLFAX ROAD
BLOCK 3517, LOT 26
TOWNSHIP OF WAYNE
PASSAIC COUNTY NEW JERSEY

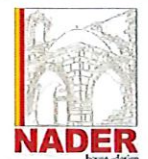

THE NADER GROUP, LLC
Architects, Engineers & Surveyors
111 Mill Street
Hockessin, NJ 07040

p. 908.850.3500 | f. 908.441.5903
e. wslm.nader@thenadergroup.com

www.naderhouseofdesign.com

CERTIFICATE OF AUTHORIZATION
Engineering & Survey
No. 24GA0013500
Architecture
No. 21AC0012600

Karen J. Wenschhof
KAREN J. WENSCHHOF
ARCHITECT, LICENSE
NO. 21A102235800
CAUTION: THIS DOCUMENT
MAY CONTAIN A RAISED
EXPRESSION SEAL OF THE
PROFESSIONAL TO BE AN
AUTHORIZED ORIGINAL.

**PLANNING
BOARD SET**


NO.	DATE	REVISION	CHK

DRAWN BY: HG
SCALE: AS SHOWN
DATE: JUNE 6TH, 2025
JOB NO. 24TH0022


FLOOR
PLANS

A-200

© 2025 NADER GROUP, NADER HOUSE OF DESIGN

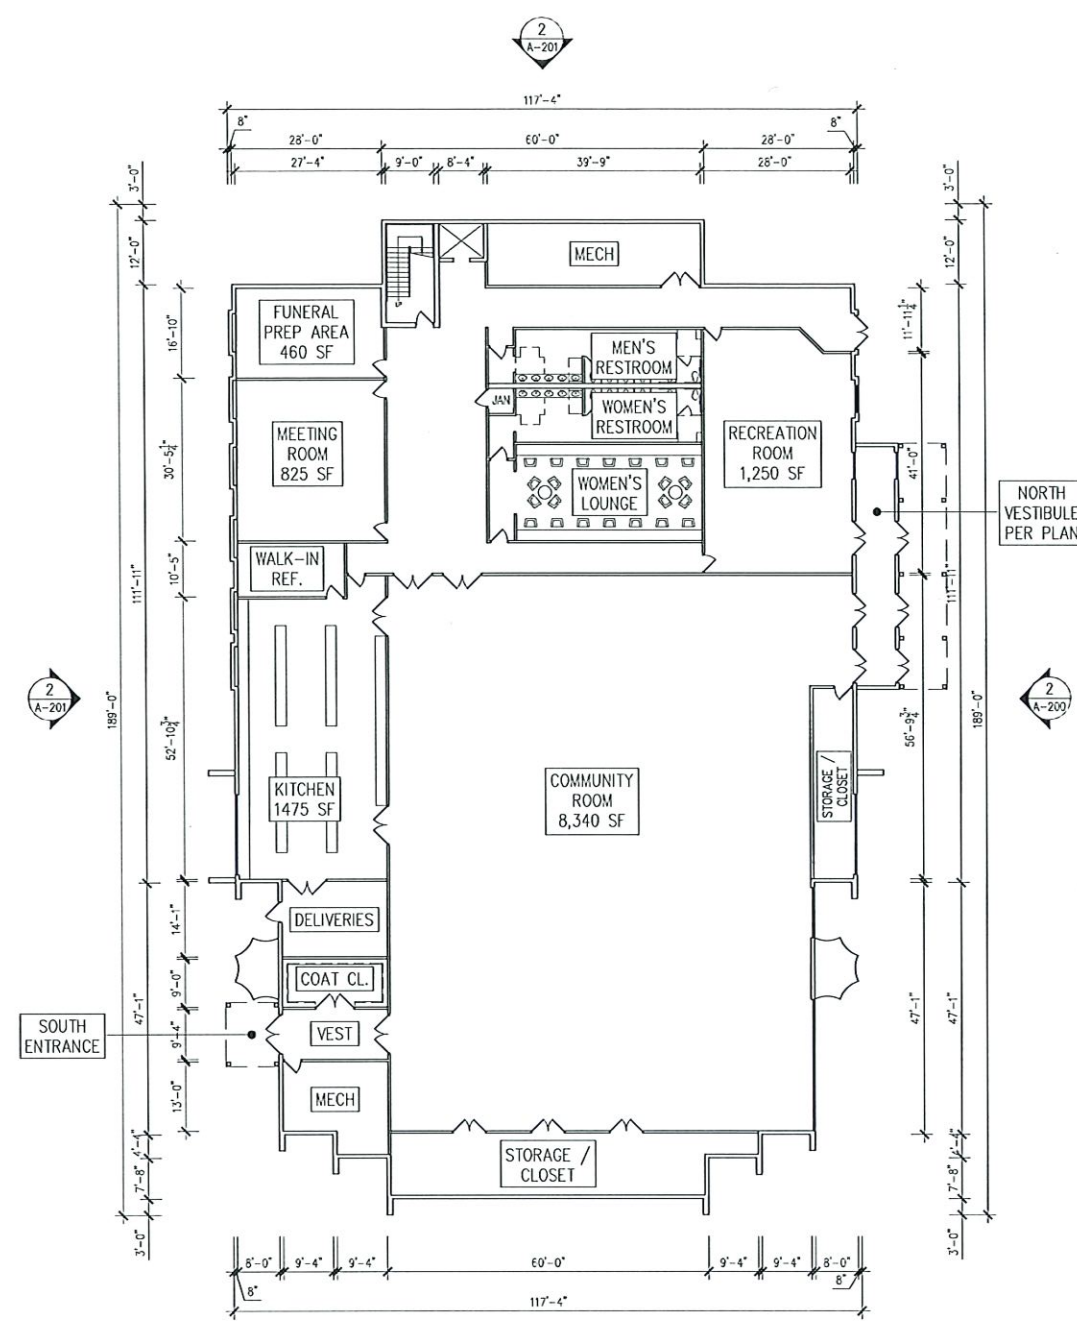


1 BASEMENT FLOOR
SCALE: 1/16" = 1'-0"

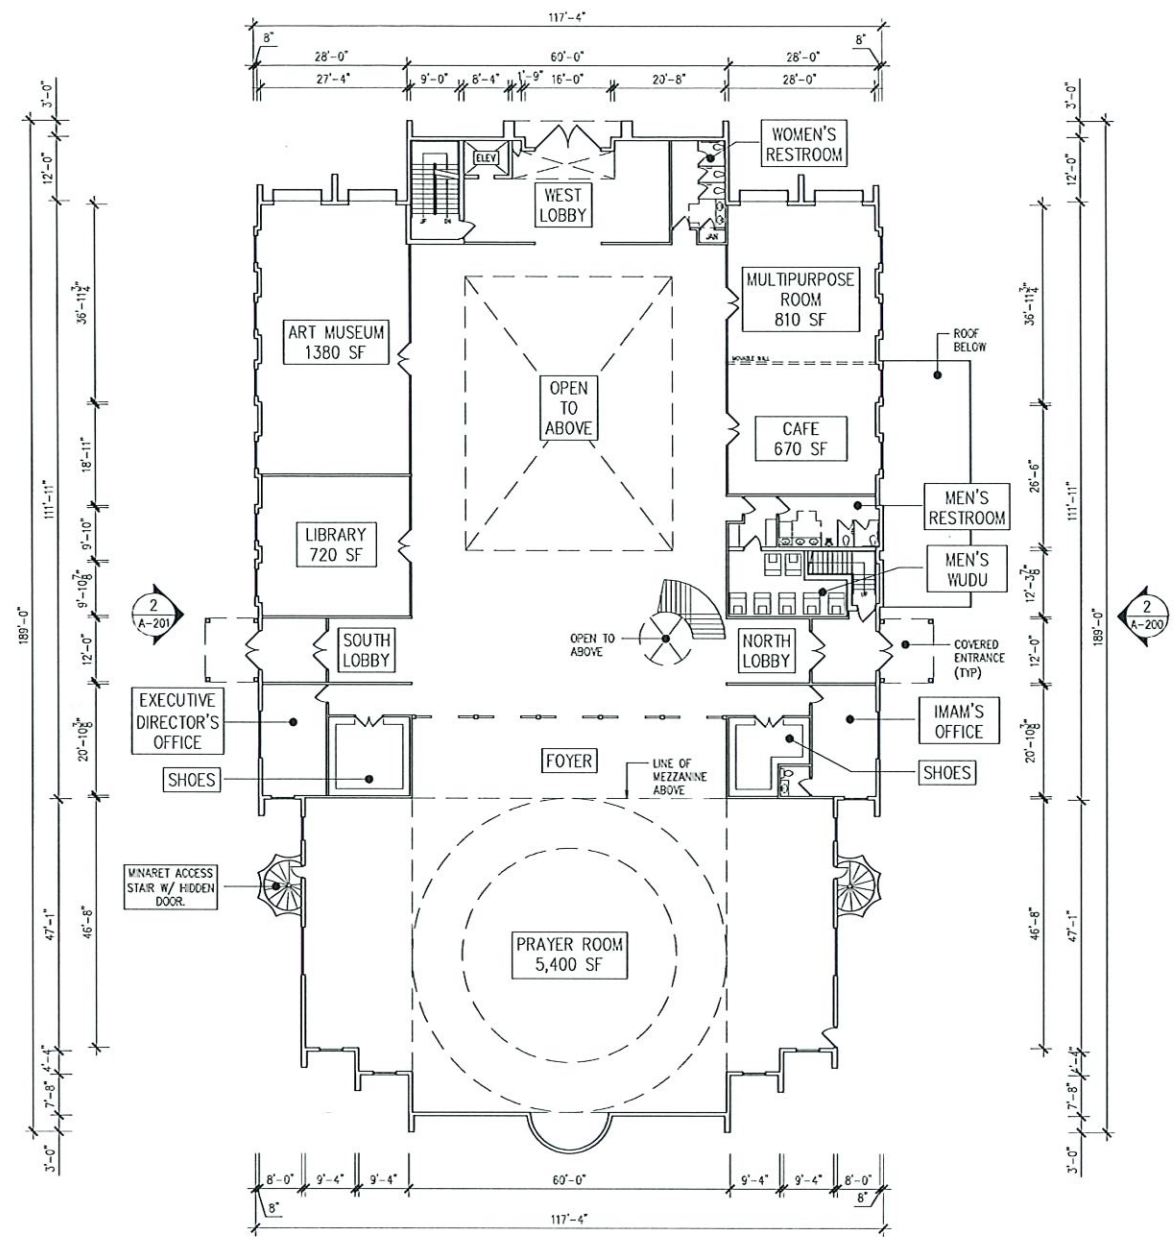


2 FIRST FLOOR
SCALE: 1/16" = 1'-0"

PLUMBING FIXTURE COUNT (PER NJ IBC TABLE 2902.1)					
USE	SQUARE FOOTAGE	OCCUPANT LOAD	REQUIRED WATER CLOSET (MALE)	REQUIRED WATER CLOSET (FEMALE)	REQUIRED LAVATORIES
PRAYER ROOM AND MEZZANINE	8400 SF	360 MEN 200 WOMEN	2.4	2.6	2.8
COMMUNITY SPACE	8340 SF	278 MEN 278 WOMEN 4 MEN	2.2	4.3	2.8
LIBRARY	720 SF	4 WOMEN	.03	.03	.04
ART MUSEUM	1380 SF	23 MEN 23 WOMEN	.2	.4	.2
CLASSROOMS & KIDS QUIET ROOM	4010 SF	200.5	4		4
MULTIPURPOSE ROOM, RECREATION ROOM & MEETING ROOM	2,865 SF	97 MEN 97 WOMEN	.8	1.5	1
CAFE	670 SF	3 MEN 3 WOMEN	.12	.12	.08
OFFICES	500 SF	2 MEN 2 WOMEN	.08	.08	.05
		TOTAL:	8	12	19

A-6 6/11/26

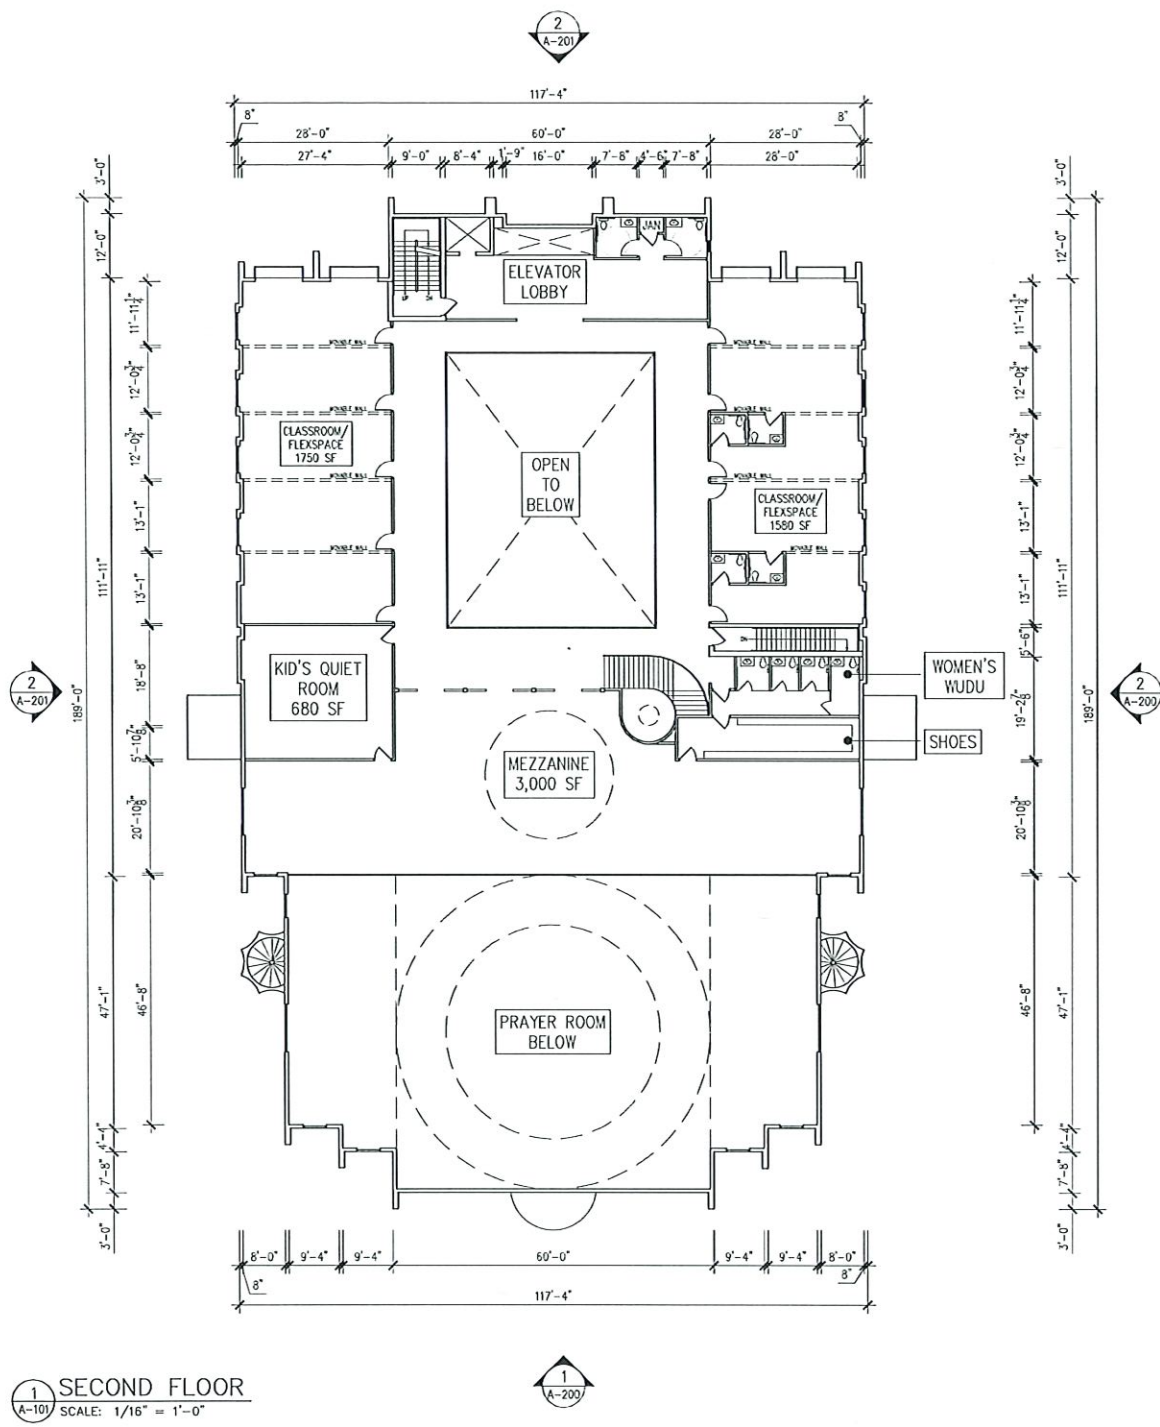


1 SECOND FLOOR
A-101 SCALE: 1/16" = 1'-0"

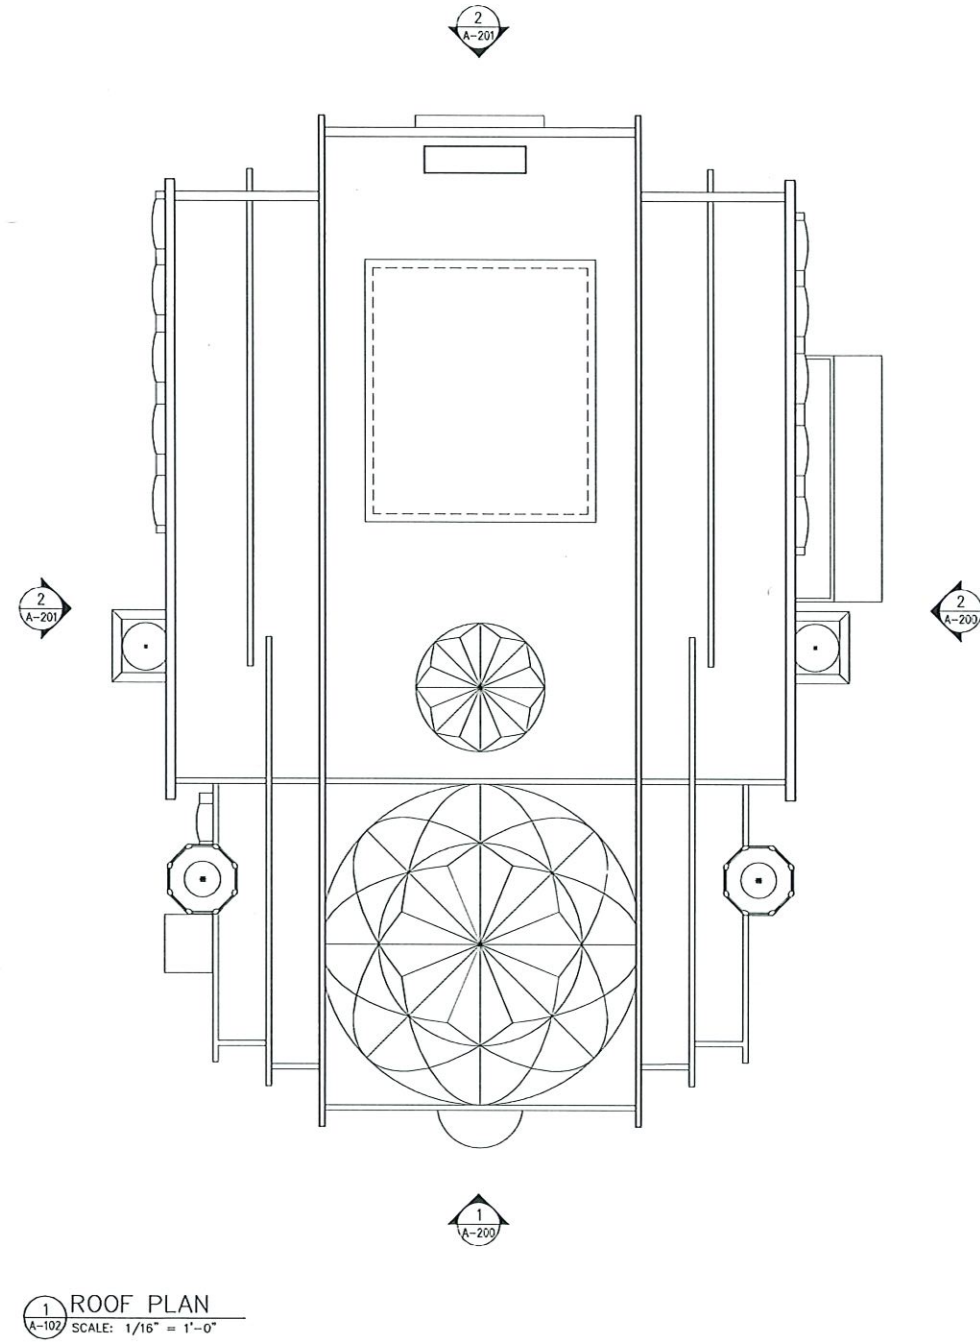

1 ROOF PLAN
A-102 SCALE: 1/16" = 1'-0"

IPRAY HOUSE
225 COLFAX ROAD
BLOCK 3517, LOT 26
TOWNSHIP OF WAYNE
PASSAIC COUNTY NEW JERSEY

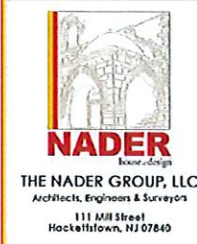

p. 908.850.3500 | f. 908.441.5503
e. waismunadar@thenadergroup.com

www.naderhouseofdesign.com

CERTIFICATE OF AUTHORIZATION
Engineering & Survey
No. 24GA02213500
Architecture
No. 21AC00124800

Karen J. Wenschhoff
KAREN J. WENSCHHOF,
ARCHITECT, LICENSE
NO. 21A0223800
CAUTION: THIS DOCUMENT
MUST CONTAIN A RAISED
IMPRESSION SEAL OF THE
PROFESSIONAL TO BE AN
AUTHORIZED ORIGINAL

PLANNING
BOARD SET

NO.	DATE	REVISION	CHK

DRAWN BY: MC
SCALE: AS SHOWN
DATE: JUNE 6TH, 2025
JOB NO. 24TH0022

FLOOR
PLANS

A-201

A-7 6/1/26



NADER
house design
THE NADER GROUP, LLC
Architect, Engineers & Surveyors
111 Mill Street
Hockessin, NJ 07040

p. 908.850.3500 | f. 908.441.5503
e. waismn@thenadergroup.com

www.naderhouseofdesign.com

CERTIFICATE OF AUTHORIZATION
Engineering & Survey
No. 24GA0223500
Architecture
No. 21AC0012600

Karen J. Wenschhoff
KAREN J. WENSCHHOFF,
ARCHITECT, LICENSE
NO. 21A10223500
CAUTION: THIS DOCUMENT
MAY BE A REPRODUCED COPY
OF THE PROFESSIONAL SEAL OF THE
AUTHORIZED ORIGINAL


PLANNING
BOARD SET

NO.	DATE	REVISION	CHK
DRAWN BY: MC			
SCALE: AS SHOWN			
DATE: JUNE 6TH, 2025			
JOB NO. 24TH0022			


ENLARGED PRAYER
ROOM AND
MEZZANINE
SEATING PLAN

CHARITABLE
A-203

© 2025 NADER GROUP, NADER HOUSE OF DESIGN

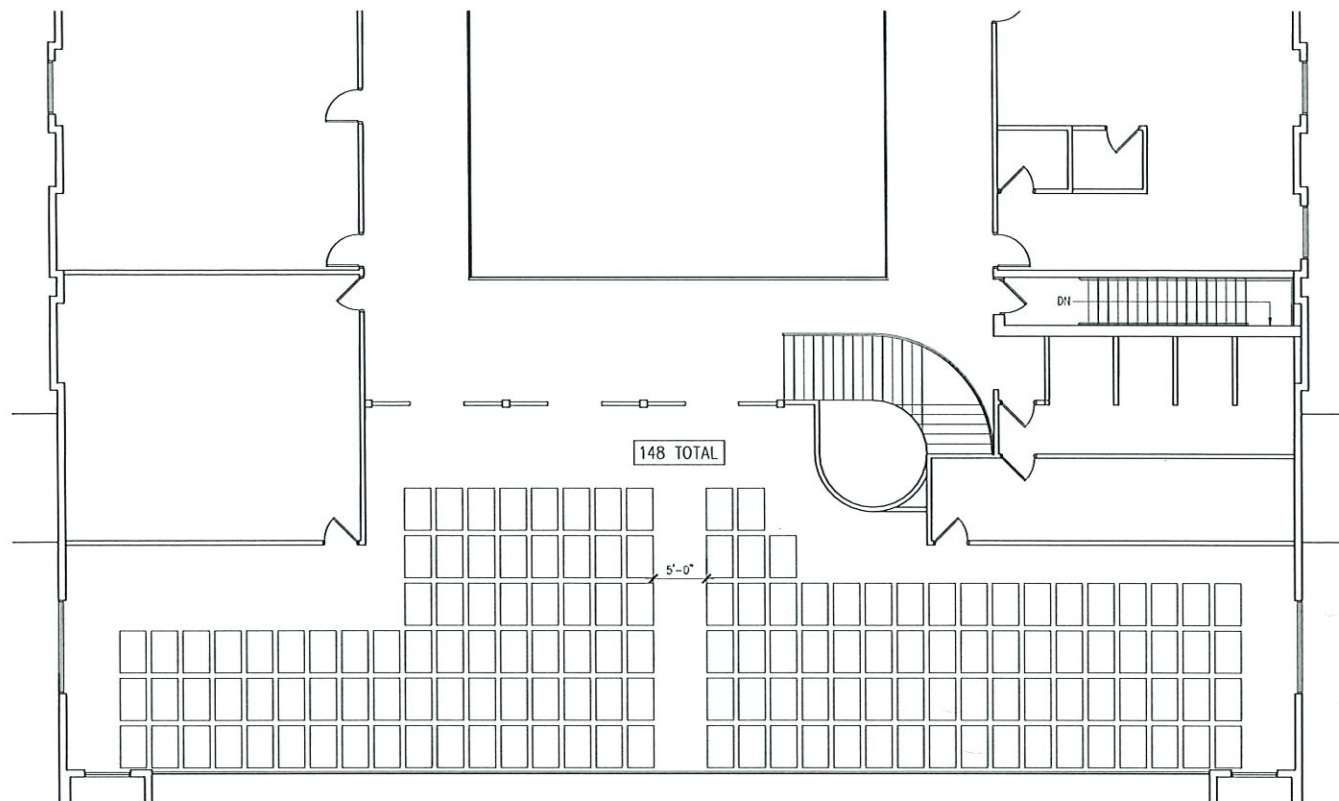


2 ENLARGED MEZZANINE SEATING PLAN
A-102 SCALE: 1/8" = 1'-0"

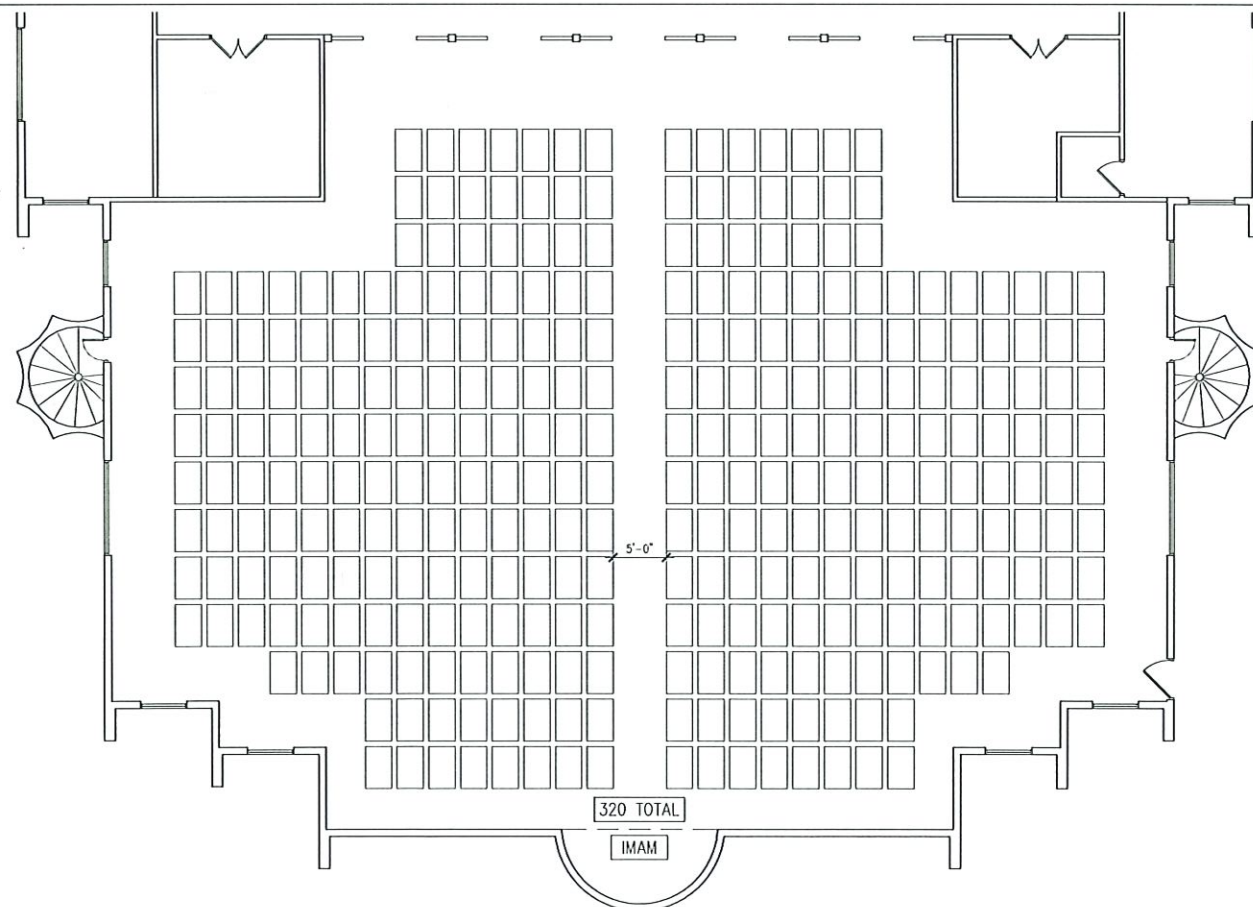


1 ENLARGED PRAYER ROOM SEATING PLAN
A-102 SCALE: 1/8" = 1'-0"

SEATING:

FIRST FLOOR PRAYER ROOM:	320 SEATS
SECOND FLOOR MEZZANINE:	148 SEATS
TOTAL:	468 SEATS

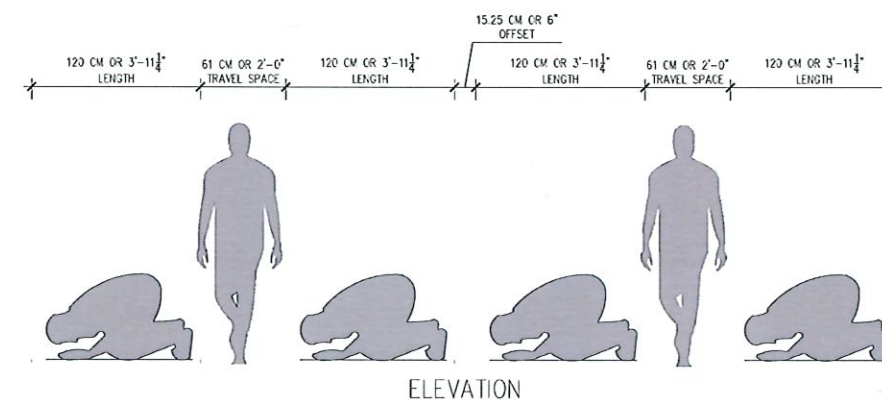

ELEVATION

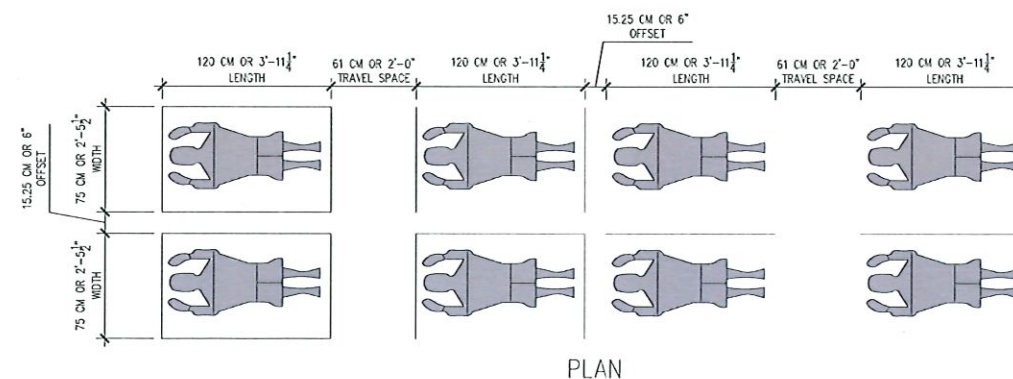

PLAN

3 PRAYER SEAT DIAGRAM
A-102 SCALE: 1/2" = 1'-0"


GENERAL SEATING SIZING DESIGNED BASED ON RESEARCH
REPORT PRODUCED FOR THE "INTERNATIONAL CONFERENCE ON
RECENT TRENDS IN URBAN MANAGEMENT, CIVIL ENGINEERING &
TECHNOLOGY IN MODERN AMERICA, GIVEN IN UAE - DUBAI",
ENTITLED "ANALYSIS OF PRAYER HALLS CAPACITY AT IRANIAN
RAILWAY STATIONS", DATED MAY 2017, BY SAYED MAHDI
SHARIFI MOGHADDAM KAKHI, MOHAMMAD KHADEM SAVENI,
SAMAN WALEKI, & SAIED MAJIDPARAST. TRAVEL PASSAGES
CONDENSED FOR USE.

A-8 6/1/24



© 2026 THE NADER GROUP LLC

IPRAY HOUSE
225 COLFAX ROAD
BLOCK 3517, LOT 26
TOWNSHIP OF WAYNE
PASSAIC COUNTY NEW JERSEY

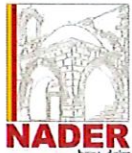

THE NADER GROUP, LLC
Architects, Engineers & Surveyors
111 Mill Street
Hackettstown, NJ 07840

p. 908.850.3500 | f. 908.441.5803
e. wassim.nader@thenadergroup.com

www.naderhouseofdesign.com

CERTIFICATE OF AUTHORIZATION
Engineering & Survey
No. 24GA38213500
Architecture
No. 21AC00124900

Karen J. Wenschof
KAREN J. WENSCHOF,
ARCHITECT, LICENSE
NO. 21A102235800
CAUTION: THIS DOCUMENT
SHOULD CONTAIN A RAISED
SUPPRESSION SEAL OF THE
PROFESSIONAL TO BE AN
AUTHORIZED ORIGINAL.

PLANNING
BOARD SET

NO.	DATE	REVISION	CHK

DRAWN BY: MC

SCALE: AS SHOWN

DATE: JUNE 6TH, 2025

JOB NO. 24THG022

INTERIOR
COURTYARD
RENDER

DATE: 6/1/26
A-301

